
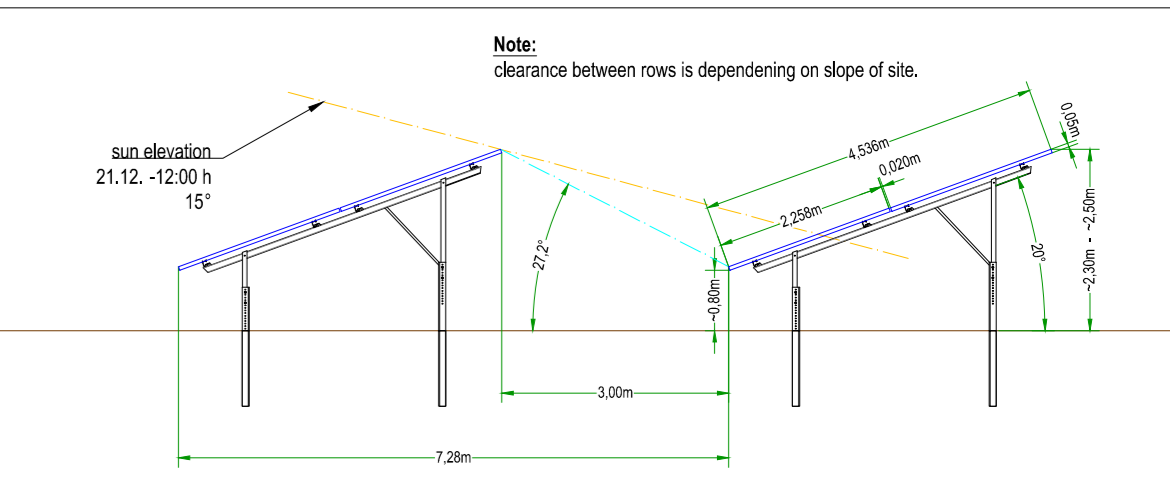


- Legend:**
- Module Unit
  - Planning boundary area
  - fence
  - gate (6m wide)
  - transformer station (8.5m)
  - storage container
  - CCTV Camera Poles(210 pcs and 3.5m high)
  - gravel road (3.5m width)
  - Public right of way
  - Habitat strip
  - Substation

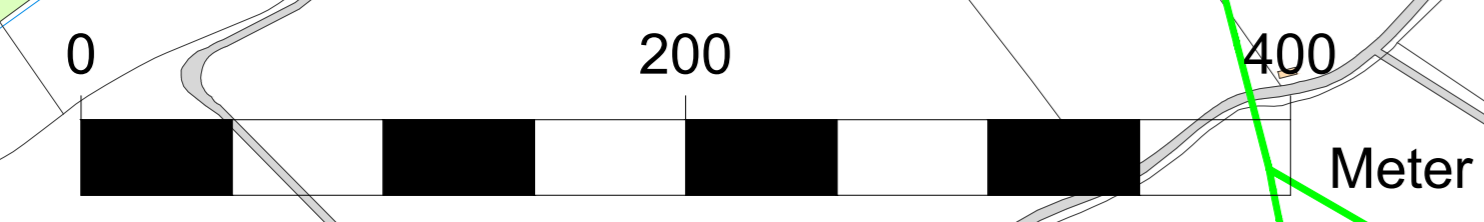

j							
h							
g							
f							
e							
d							
c							
b							
a							
Index	Date	Name	Editor	Modification / Adaptation of the drawing			
				Project: <b>Perrinpit Road</b> The UK PV Power Plant			
			Client: <b>Perrinpit Road Solar Limited</b>				
Drawn	16.09.2020	sur	Planning Period:				Scale
Changed							1:2500
Checked							Format
Drawing Title:	EXT_module layout for website						A0
File Name:	BWre20-PPT_PD.dwg						